

SUB CONTRACTOR:
 T & C QATAR L.L.C. - C.R. 35109
 P.O. Box: 2329 DOHA, QATAR
 TEL: (+974) 4421 833 / 4930 614
 FAX: (+974) 4410 553 / 4930 614



CONSULTANT:
 المكتب العربي للتقنية
ARAB ENGINEERING BUREAU
 Phone: +974 4477 161 Fax: +974 4477 888 P.O. Box 148 Doha Qatar
 Email: ae@ae-qatar.com Web: www.ae-qatar.com

DESIGNER:
 GHD
 PO Box 14263 Doha Qatar
 T: 974 4322178 F: 974 4449127
 E: dcm@ghd.com.au www.ghd.com.au

MAIN CONTRACTOR:
AL MADAR
 GROUP W.L.L. مجموعة المادار
 AL MADAR CONTRACTING
 P.O. Box: 2329 DOHA, QATAR
 TEL: (+974) 4675405 - 4674466
 FAX: (+974) 4671333 - C.R. : 15061
 WEB SITE: www.almadar-group.com
 Email: conteng@almadar-group.com

OWNER:
 ALI ABDUL REDA MASHHADI

PROJECT:
 AL NOOR OFFICE TOWER AT NEW DOHA
 2B+G+F+22 FLOORS

DRAWING TITLE:
 FIRST FLOOR
 EXTRA LOW VOLTAGE
 (F.A.S. & CCTV)

DRAWING REFERENCE:
 75-10288-FAS-008 - FIRST FLOOR FIRE ALARM SYSTEM
 75-10288-FAS-001 - FIRE ALARM SYSTEM SCHEMATIC DIAGRAM
 75-10288-FAS-002 - FIRE ALARM SYSTEM SCHEMATIC DIAGRAM
 75-10288-E204 - POWER & LOW CURRENT LAYOUT

DRAWN BY D. CESARONI

CHECKED BY M. SHAMIMUDDIN

APPROVED BY M. MOHAMUD


DATE 04.07.07

SCALE 1:50 SIZE A0

REVISION 0

DATE 04.07.07

DRAWING NO. TC01E4F01043
 SHEET 2 OF 2

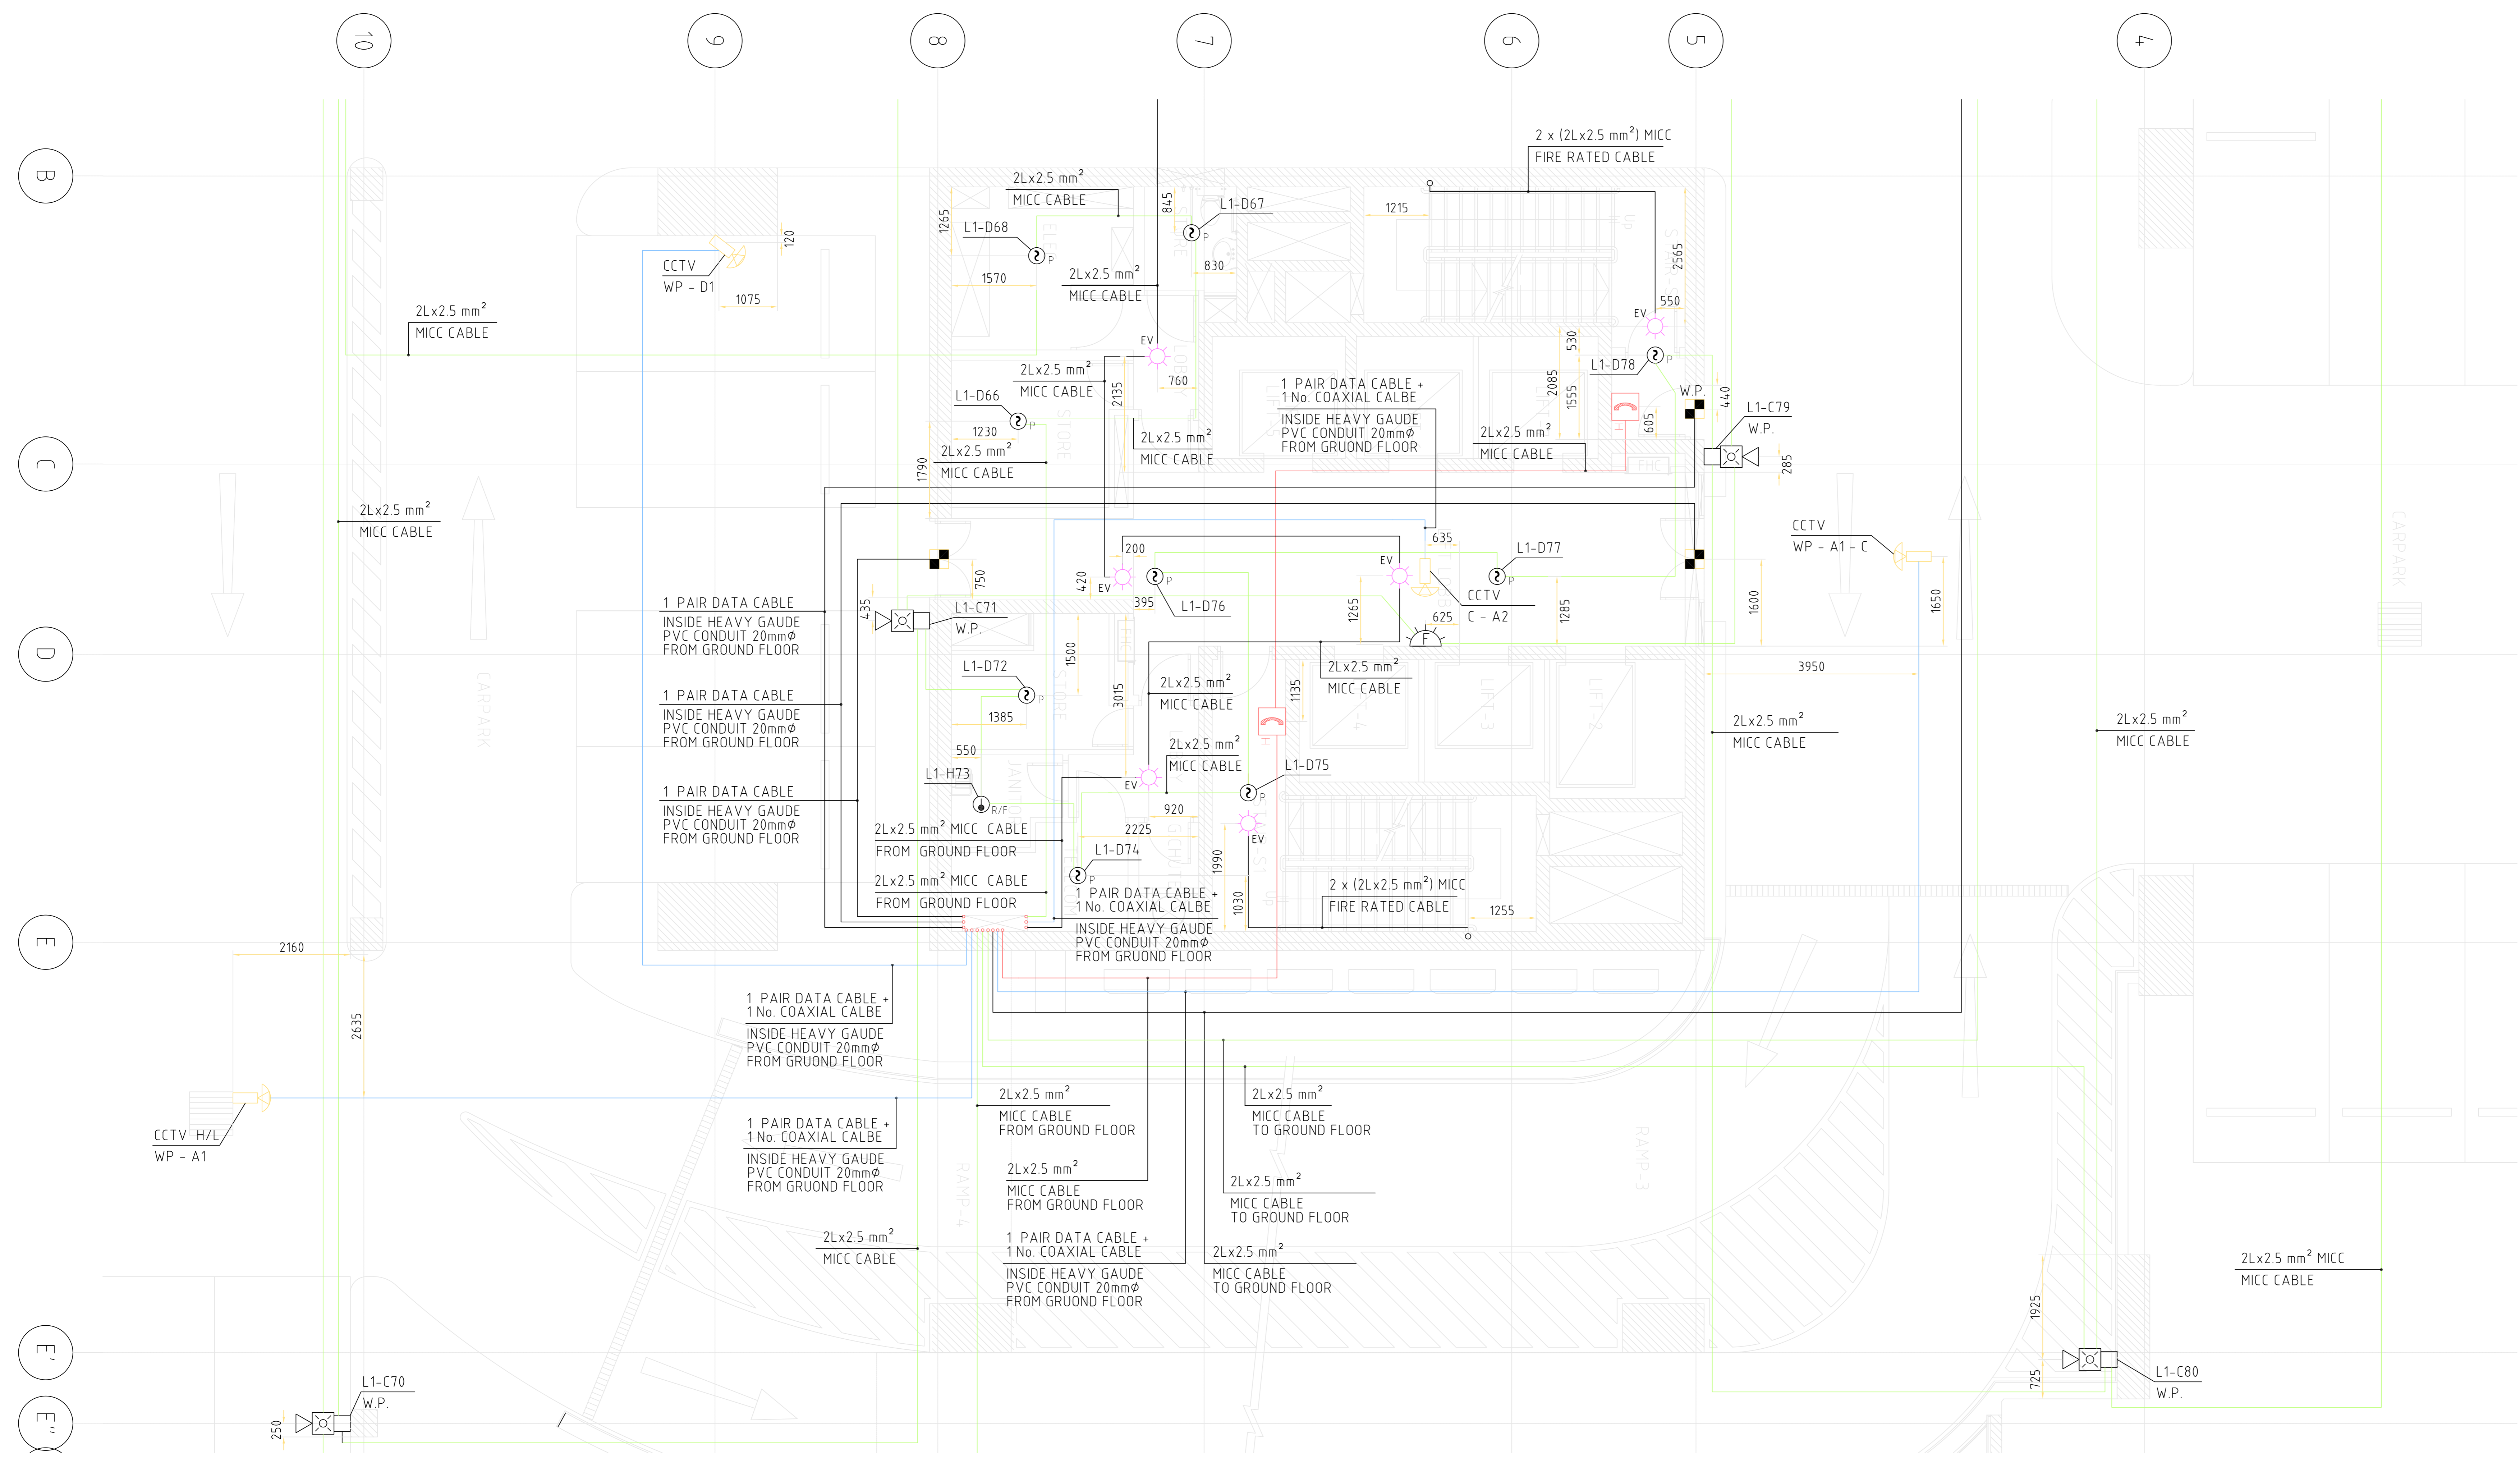

	ADDRESSABLE TYPE MANUAL CALL POINT WP : WEATHER PROOF
	ADDRESSABLE TYPE SMOKE DETECTOR (PHOTO ELECTRIC)
	ADDRESSABLE TYPE HEAT DETECTOR (RATE OF RISE/FIXED)
	HORN WITH FLASHER (HORN WITH LIGHT ONE ASSEMBLY)
	FLASHER
	FIRE SERVICES EMERGENCY TELEPHONE UNIT IN RECESSED APPROVED ENCLOSURE
	EWIS SPEAKERS
	DOOR CONTACT / READ SWITCH WP : WEATHER PROOF
	MICC CABLE RUNNING EXPOSED OTHERWISE AS INDICATED
	CCTV CAMERA A : PTZ/FULL FUNCTION CAMERA, CEILING MOUNTED A1: DITTO AS "A" ABOVE BUT DOME TYPE A2: PTZ/FULL FUNCTION DOME TYPE RECESSED IN FALSE CEILING A3: PTZ/FULL FUNCTION DOME TYPE CAMERA MOUNTED ON POLE B : PTZ/FULL FUNCTION CAMERA, WALL MOUNTED B1: DITTO AS "B" ABOVE BUT DOME TYPE C : FIXED CAMERA, RECESSED IN FALSE CEILING, DOME TYPE C1: DITTO AS "C" ABOVE BUT DOME TYPE C2: FIXED CAMERA CEILING MOUNTED DOME TYPE D : FIXED CAMERA, WALL MOUNTED D1: DITTO AS "D" ABOVE BUT DOME TYPE WP : WEATHER PROOF

