
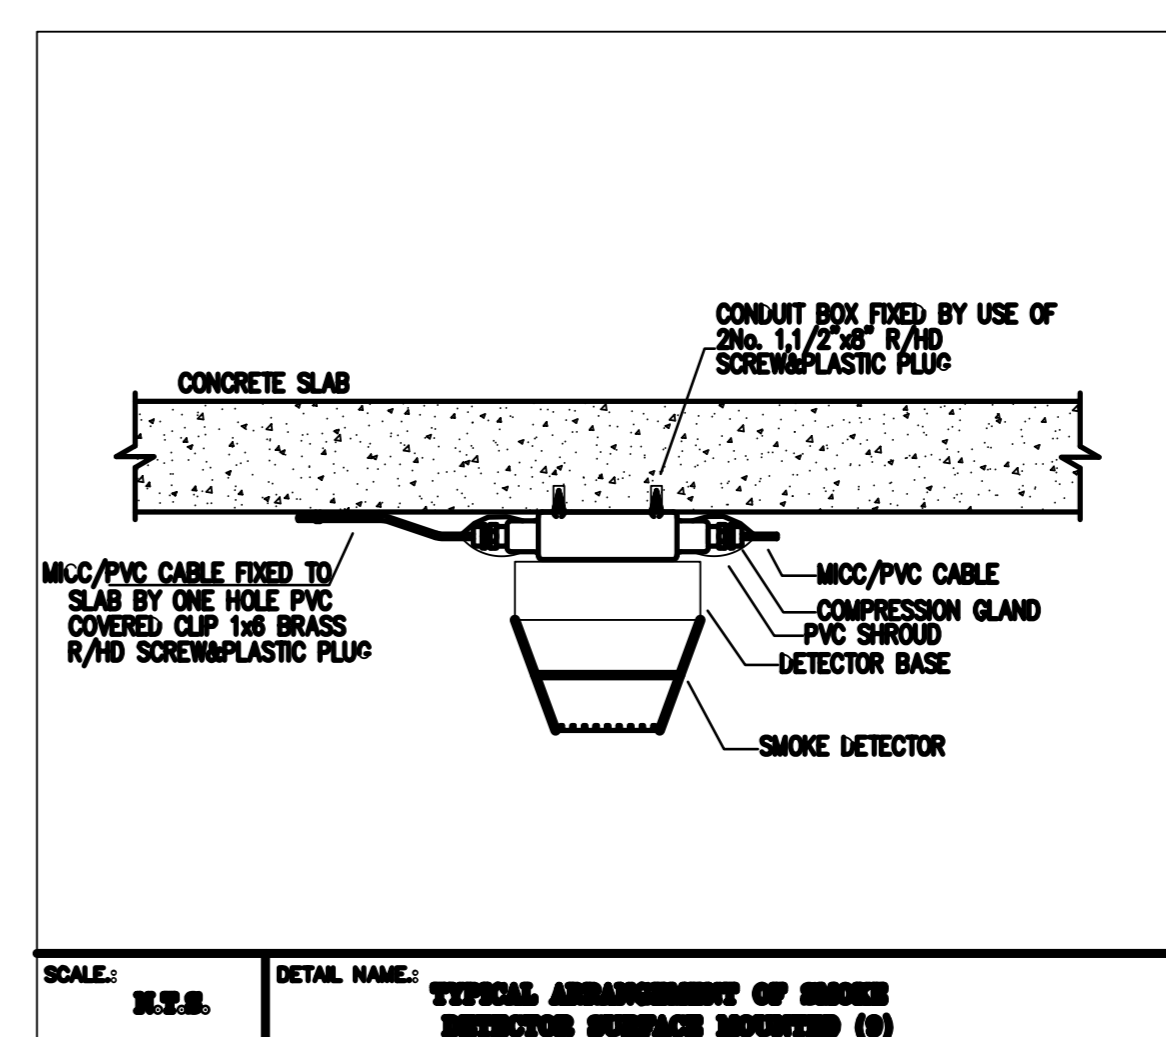
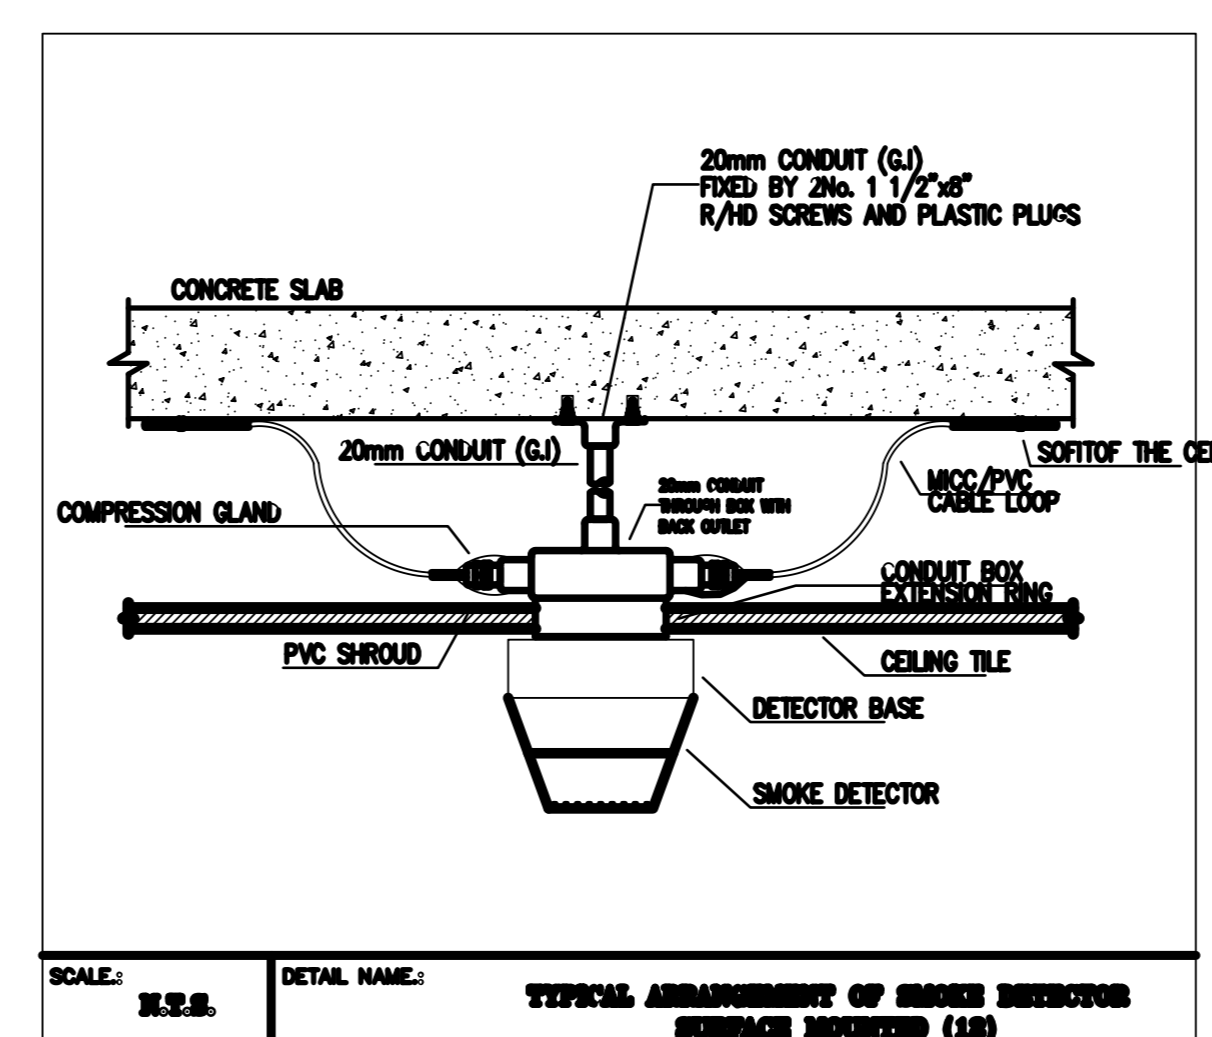
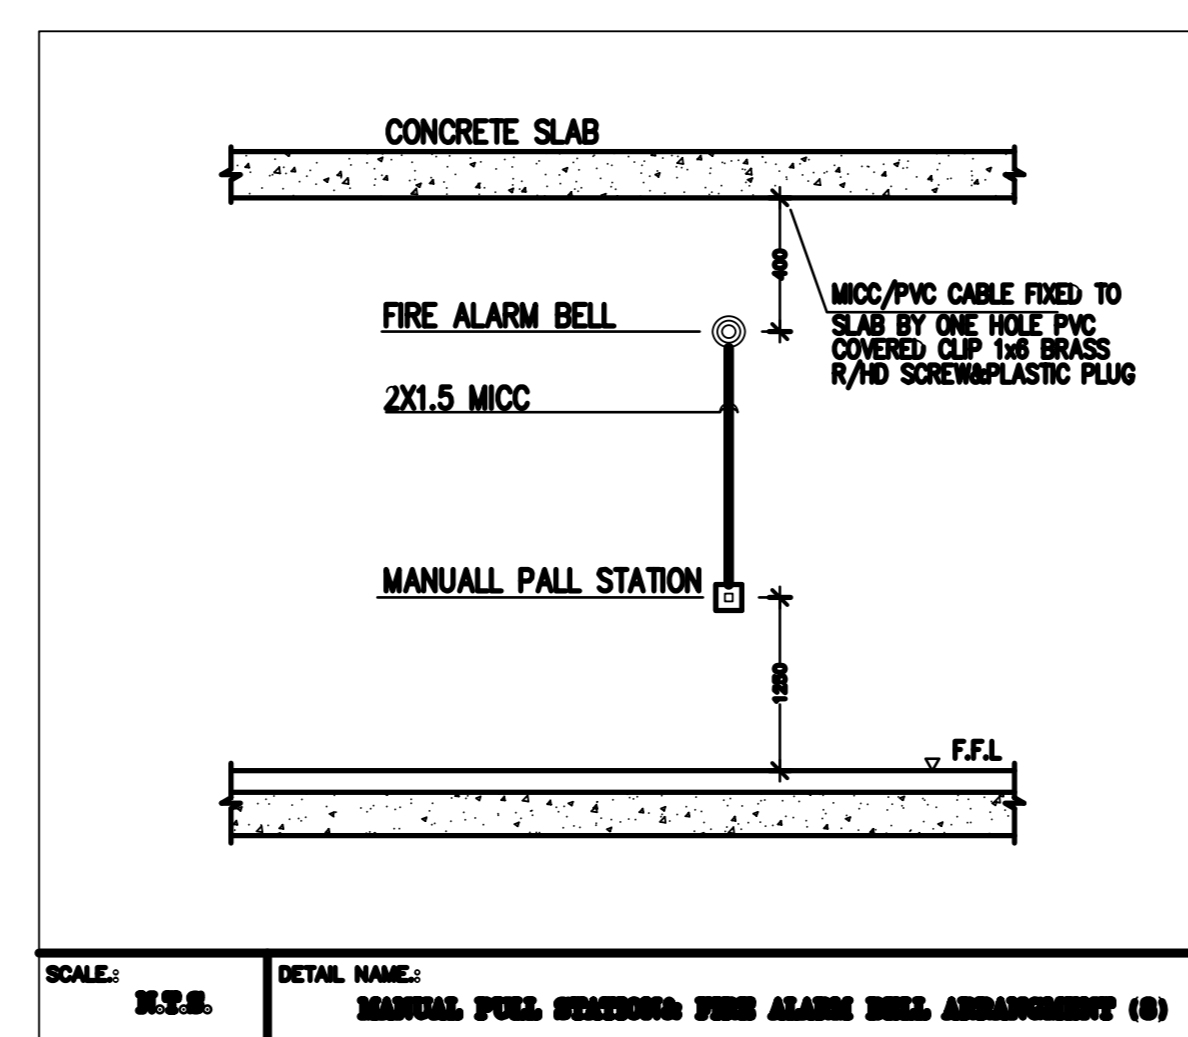


	ADDRESSABLE TYPE SMOKE DETECTOR (PHOTO ELECTRIC)
	ADDRESSABLE TYPE HEAT DETECTOR (RATE OF RISE/FIXED)
	ADDRESSABLE TYPE MANUAL CALL POINT WP : WEATHER PROOF
	ADDRESSABLE OUTPUT MODULE (CONTROL MODULE)
	FIRE ALARM SOUNDER WITH FLASHER (BELL-VIBRATING/STROBE) WP : WEATHER PROOF
	FLASHER
	FIRE SERVICES EMERGENCY TELEPHONE UNIT IN RECESSED APPROVED ENCLOSURE
	EWS SPEAKERS
	TV JUNCTION BOX
	DIGITAL KILOWATT HOUR METER
	2Lx2.5 mm ² MICC CABLE RUNNING EXPOSED (OTHERWISE AS INDICATED)

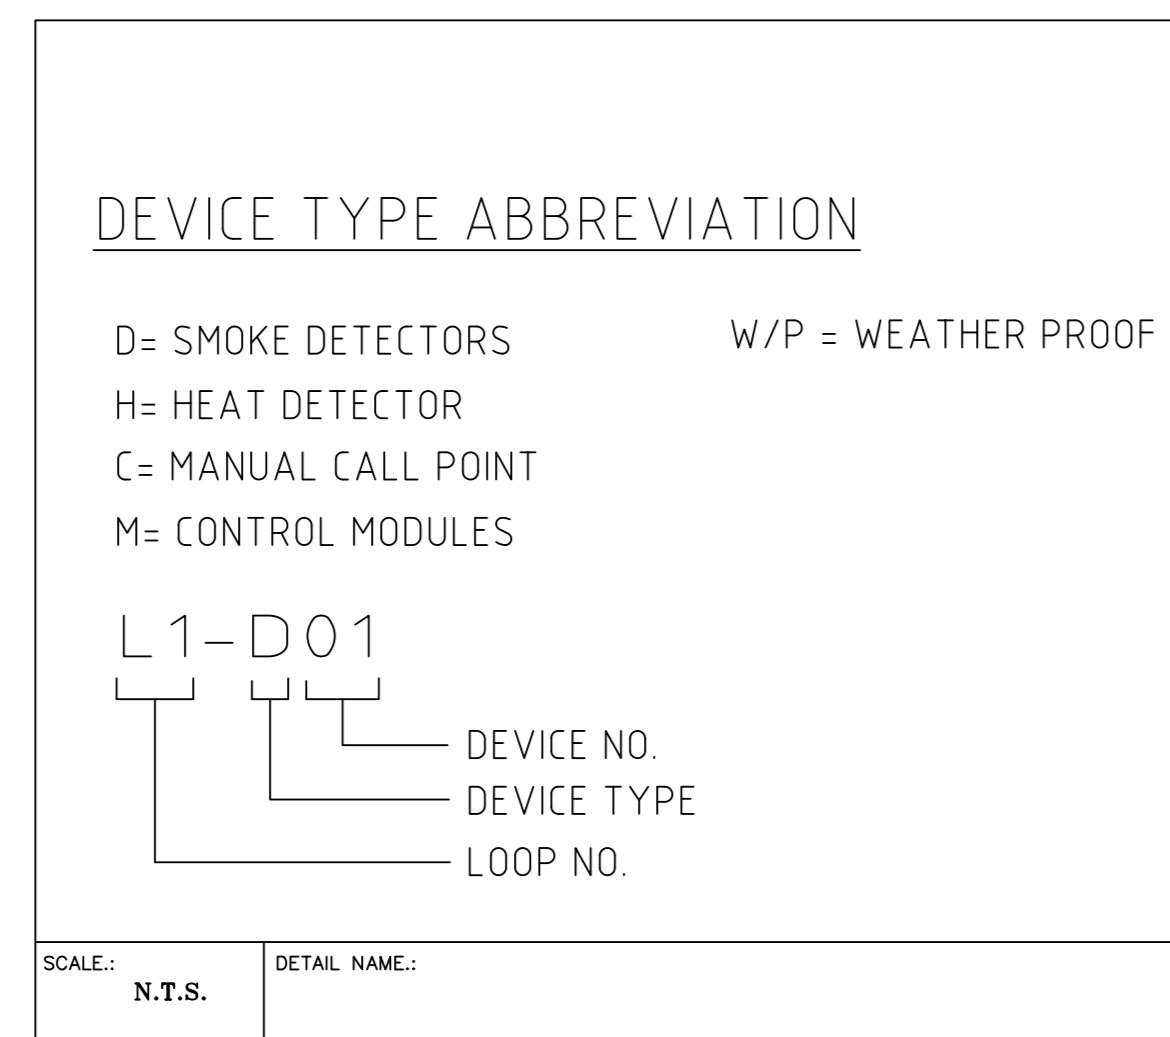

SUB CONTRACTOR:
T & C QATAR L.L.C. - C.R. 35109
P.O. Box: 2329 DOHA, QATAR
TEL: (+974) 4421 833 / 4930 614
FAX: (+974) 4410 553 / 4930 614

CONSULTANT:

المكتب العربي للهندسة
ARAB ENGINEERING BUREAU
تلفون: 4471 881 / 4471 888 / 4471 889 / 4471 890 / 4471 891 / 4471 892 / 4471 893 / 4471 894 / 4471 895 / 4471 896 / 4471 897 / 4471 898 / 4471 899 / 4471 900
فكس: 4471 881 / 4471 888 / 4471 889 / 4471 890 / 4471 891 / 4471 892 / 4471 893 / 4471 894 / 4471 895 / 4471 896 / 4471 897 / 4471 898 / 4471 899 / 4471 900
www.aeb-qatar.com

DESIGNER:

GHD
P.O. Box: 14302 Doha Qatar
T 974 4322279 F 974 4466127
www.ghd.com.au

MAIN CONTRACTOR:

AL MADAR CONTRACTING
P.O. Box: 2329 DOHA, QATAR
TEL: (+974) 4675405 - 4674466
FAX: (+974) 4671333 - C.R. : 15061
WEB SITE: www.almador-group.com
Email: conteng@almador-group.com

OWNER:
ALI ABDUL REDA MASHHADI

PROJECT:
AL NOOR OFFICE TOWER AT NEW DOHA
2B+G+F+22 FLOORS

DRAWING TITLE:
24 TH FLOOR PLAN
LOW CURRENT LAYOUT

DRAWING REFERENCE:

75-10288-FAS-001 - FIRE ALARM SCHEMATIC DIAGRAM
75-10288-FAS-002 - FIRE ALARM GENERAL DETAILS
75-10288-FAS-004 - FIRE ALARM LEGEND & GENERAL NOTES
75-10288-FAS-010 - 24 TH FLOOR FIRE ALARM LAYOUT
75-10288-E206 - 24 TH FLOOR POWER LAYOUT

DRAWN BY: D. CESARONI

CHECKED BY: M. SHAMIMUDDIN

APPROVED BY: M. MOHAMUD

DATE: 11.07.07

SCALE: 1:100 **SIZE:** A0

REVISION: 0

DATE: 11.07.07

DRAWING NO.: TC01E4T01045_L24
SHEET: 1 OF 2